

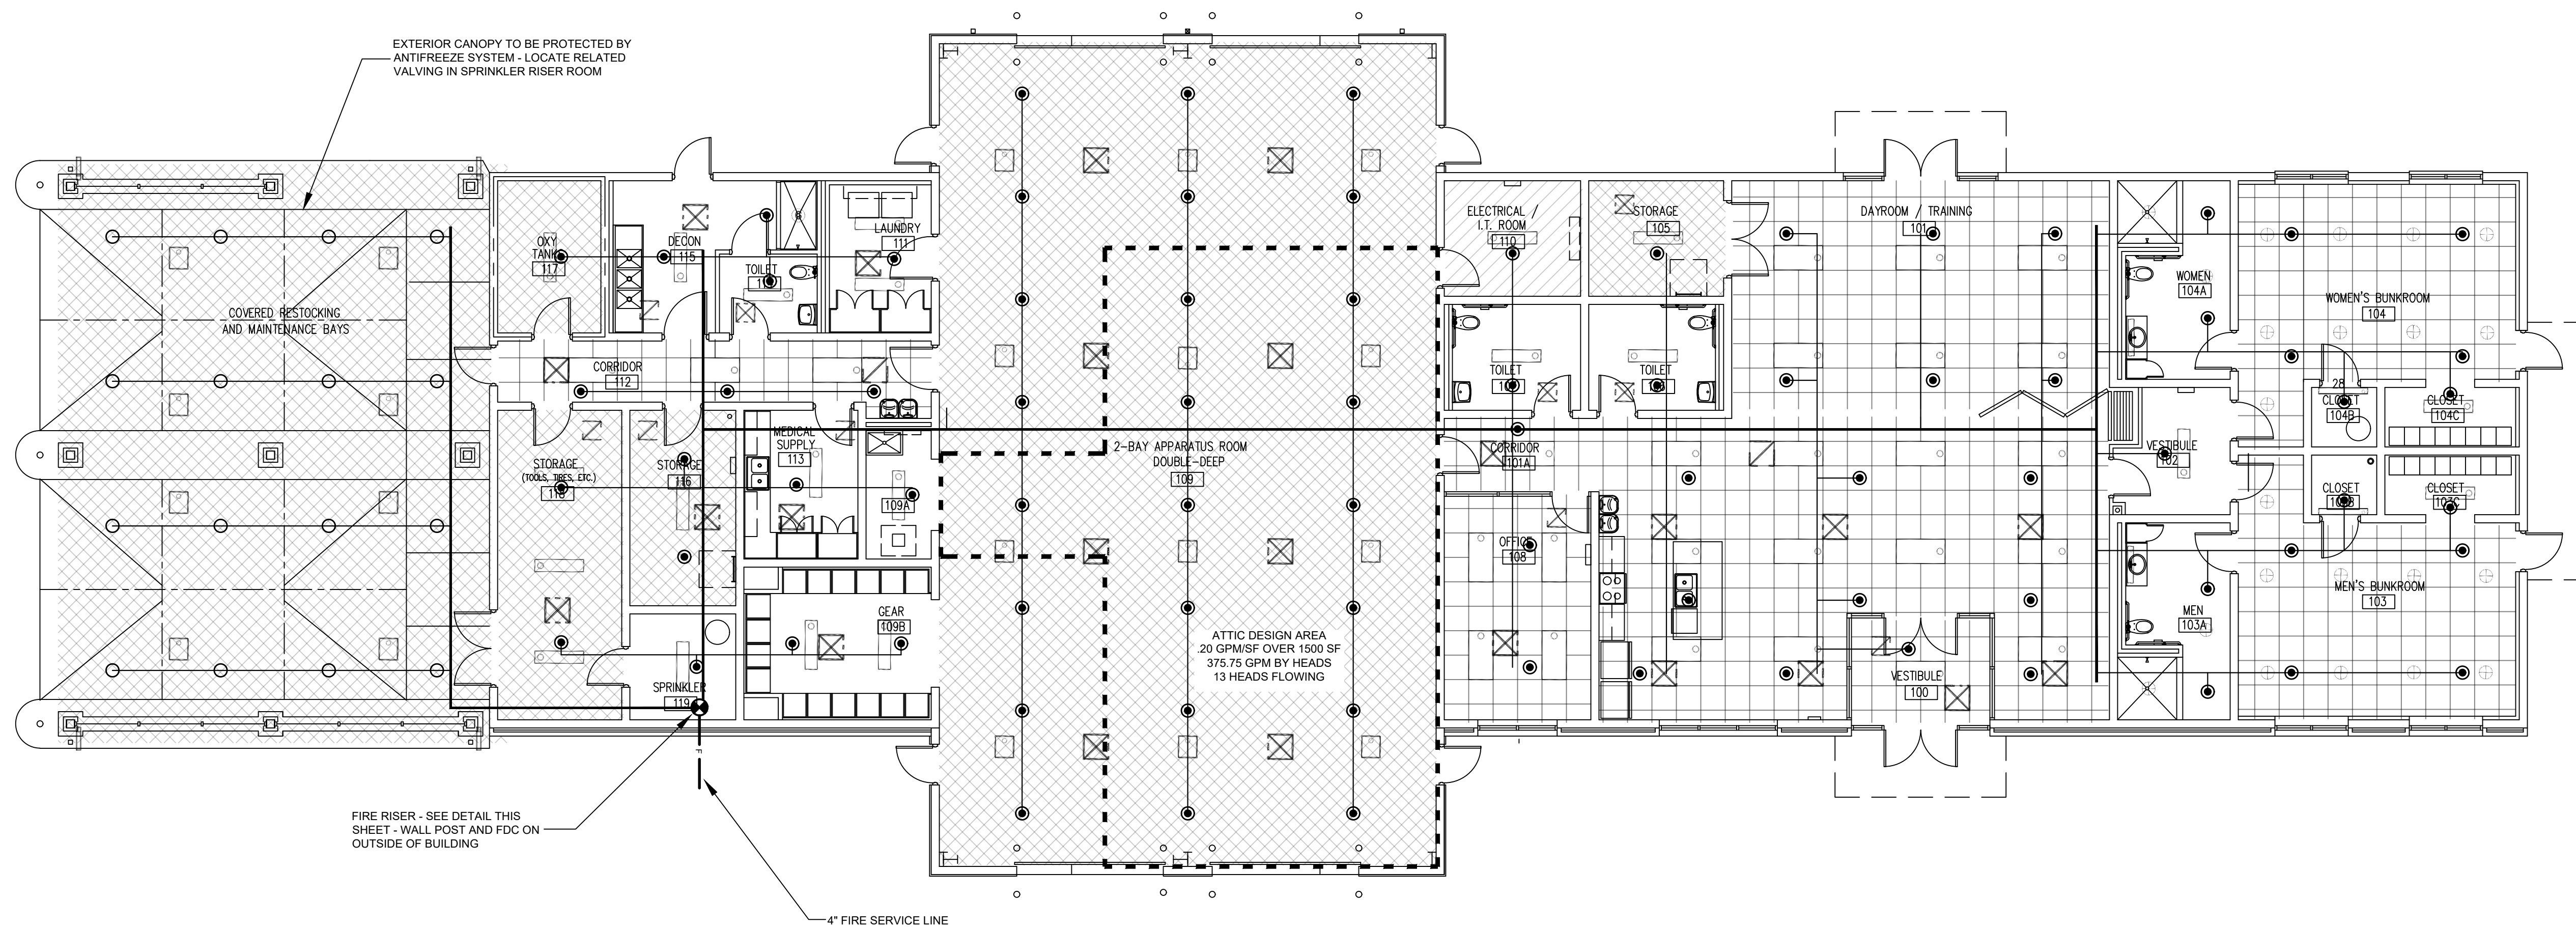
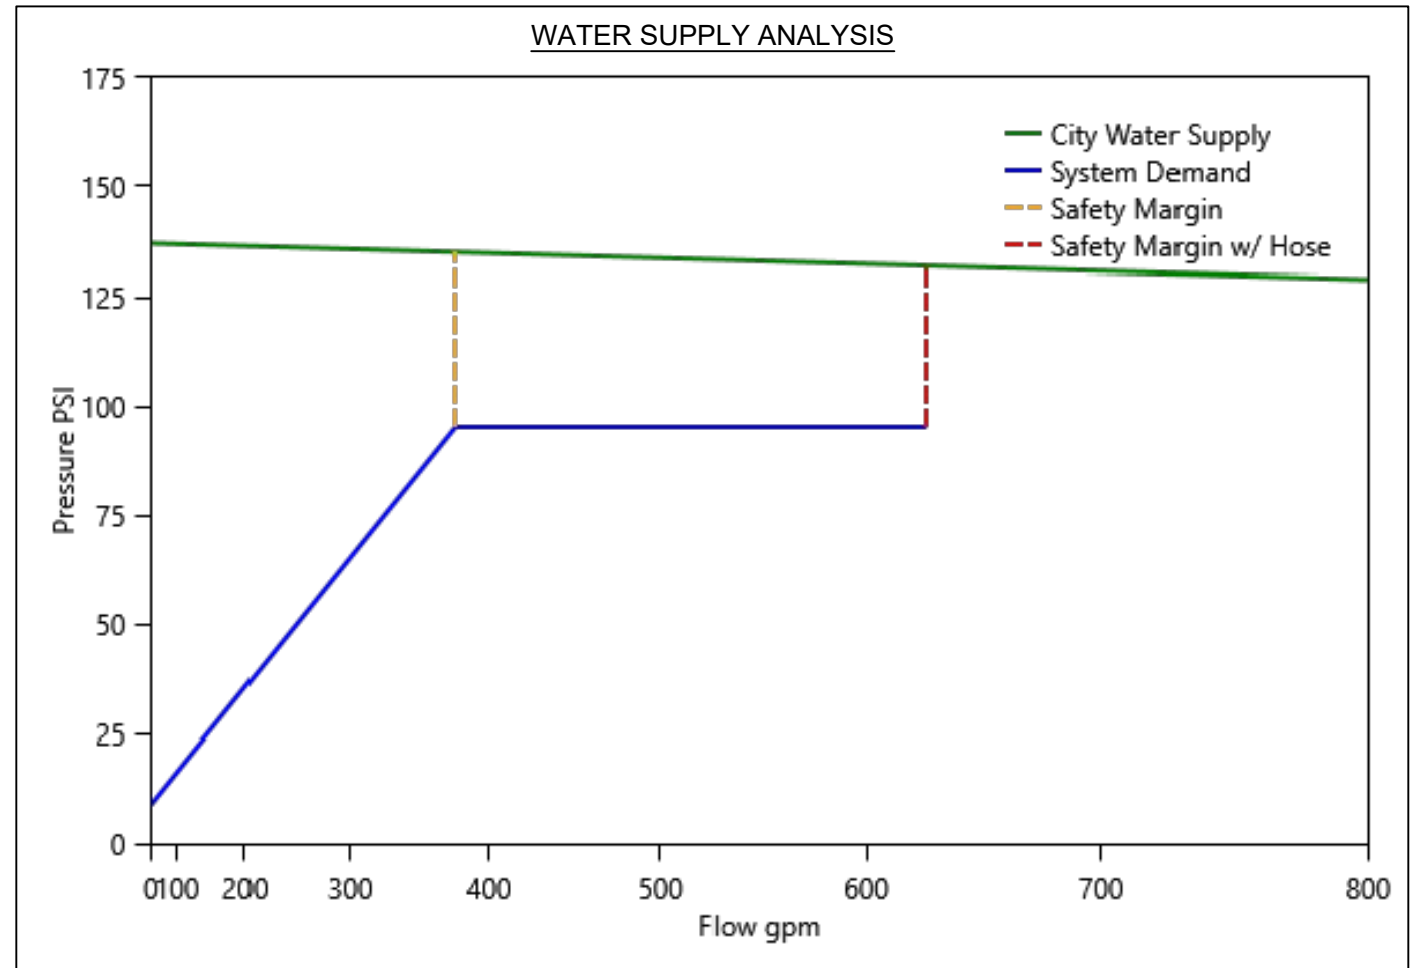


DATE:	06-03-2026
NO.	REVISION DATE
1	06-03-2026
2	
3	
SHEET:	FP101
DRAWN BY:	NAL
CHECKED BY:	NAL
PROJECT NO.:	TLG-2515
THE LANE GROUP INC.	

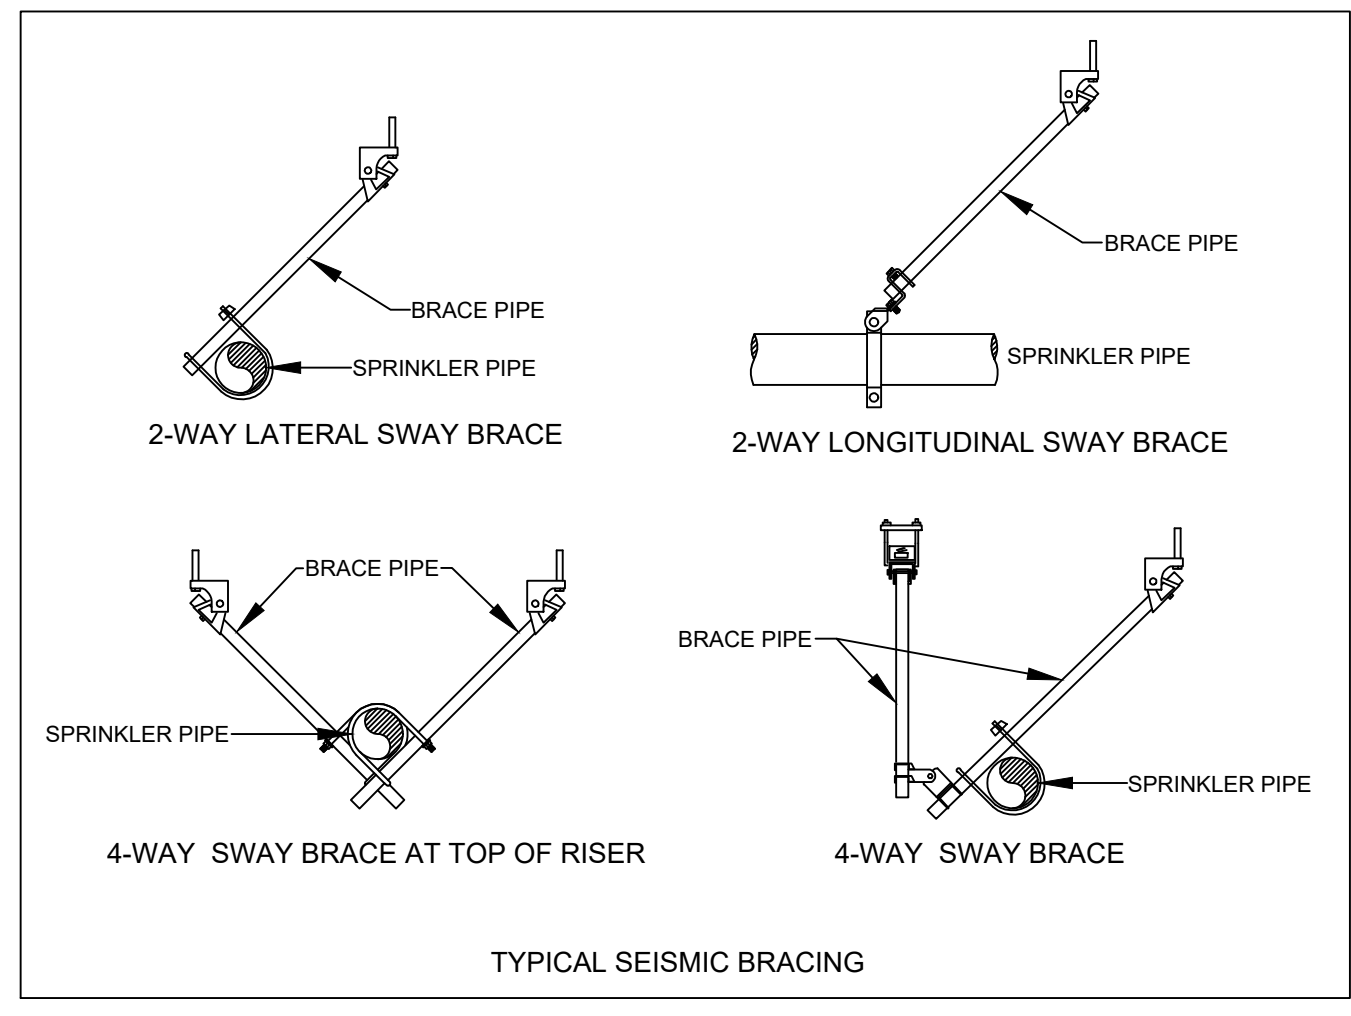

**FIRE PROTECTION FLOOR PLAN**

SCALE: 1/8" = 1'-0"

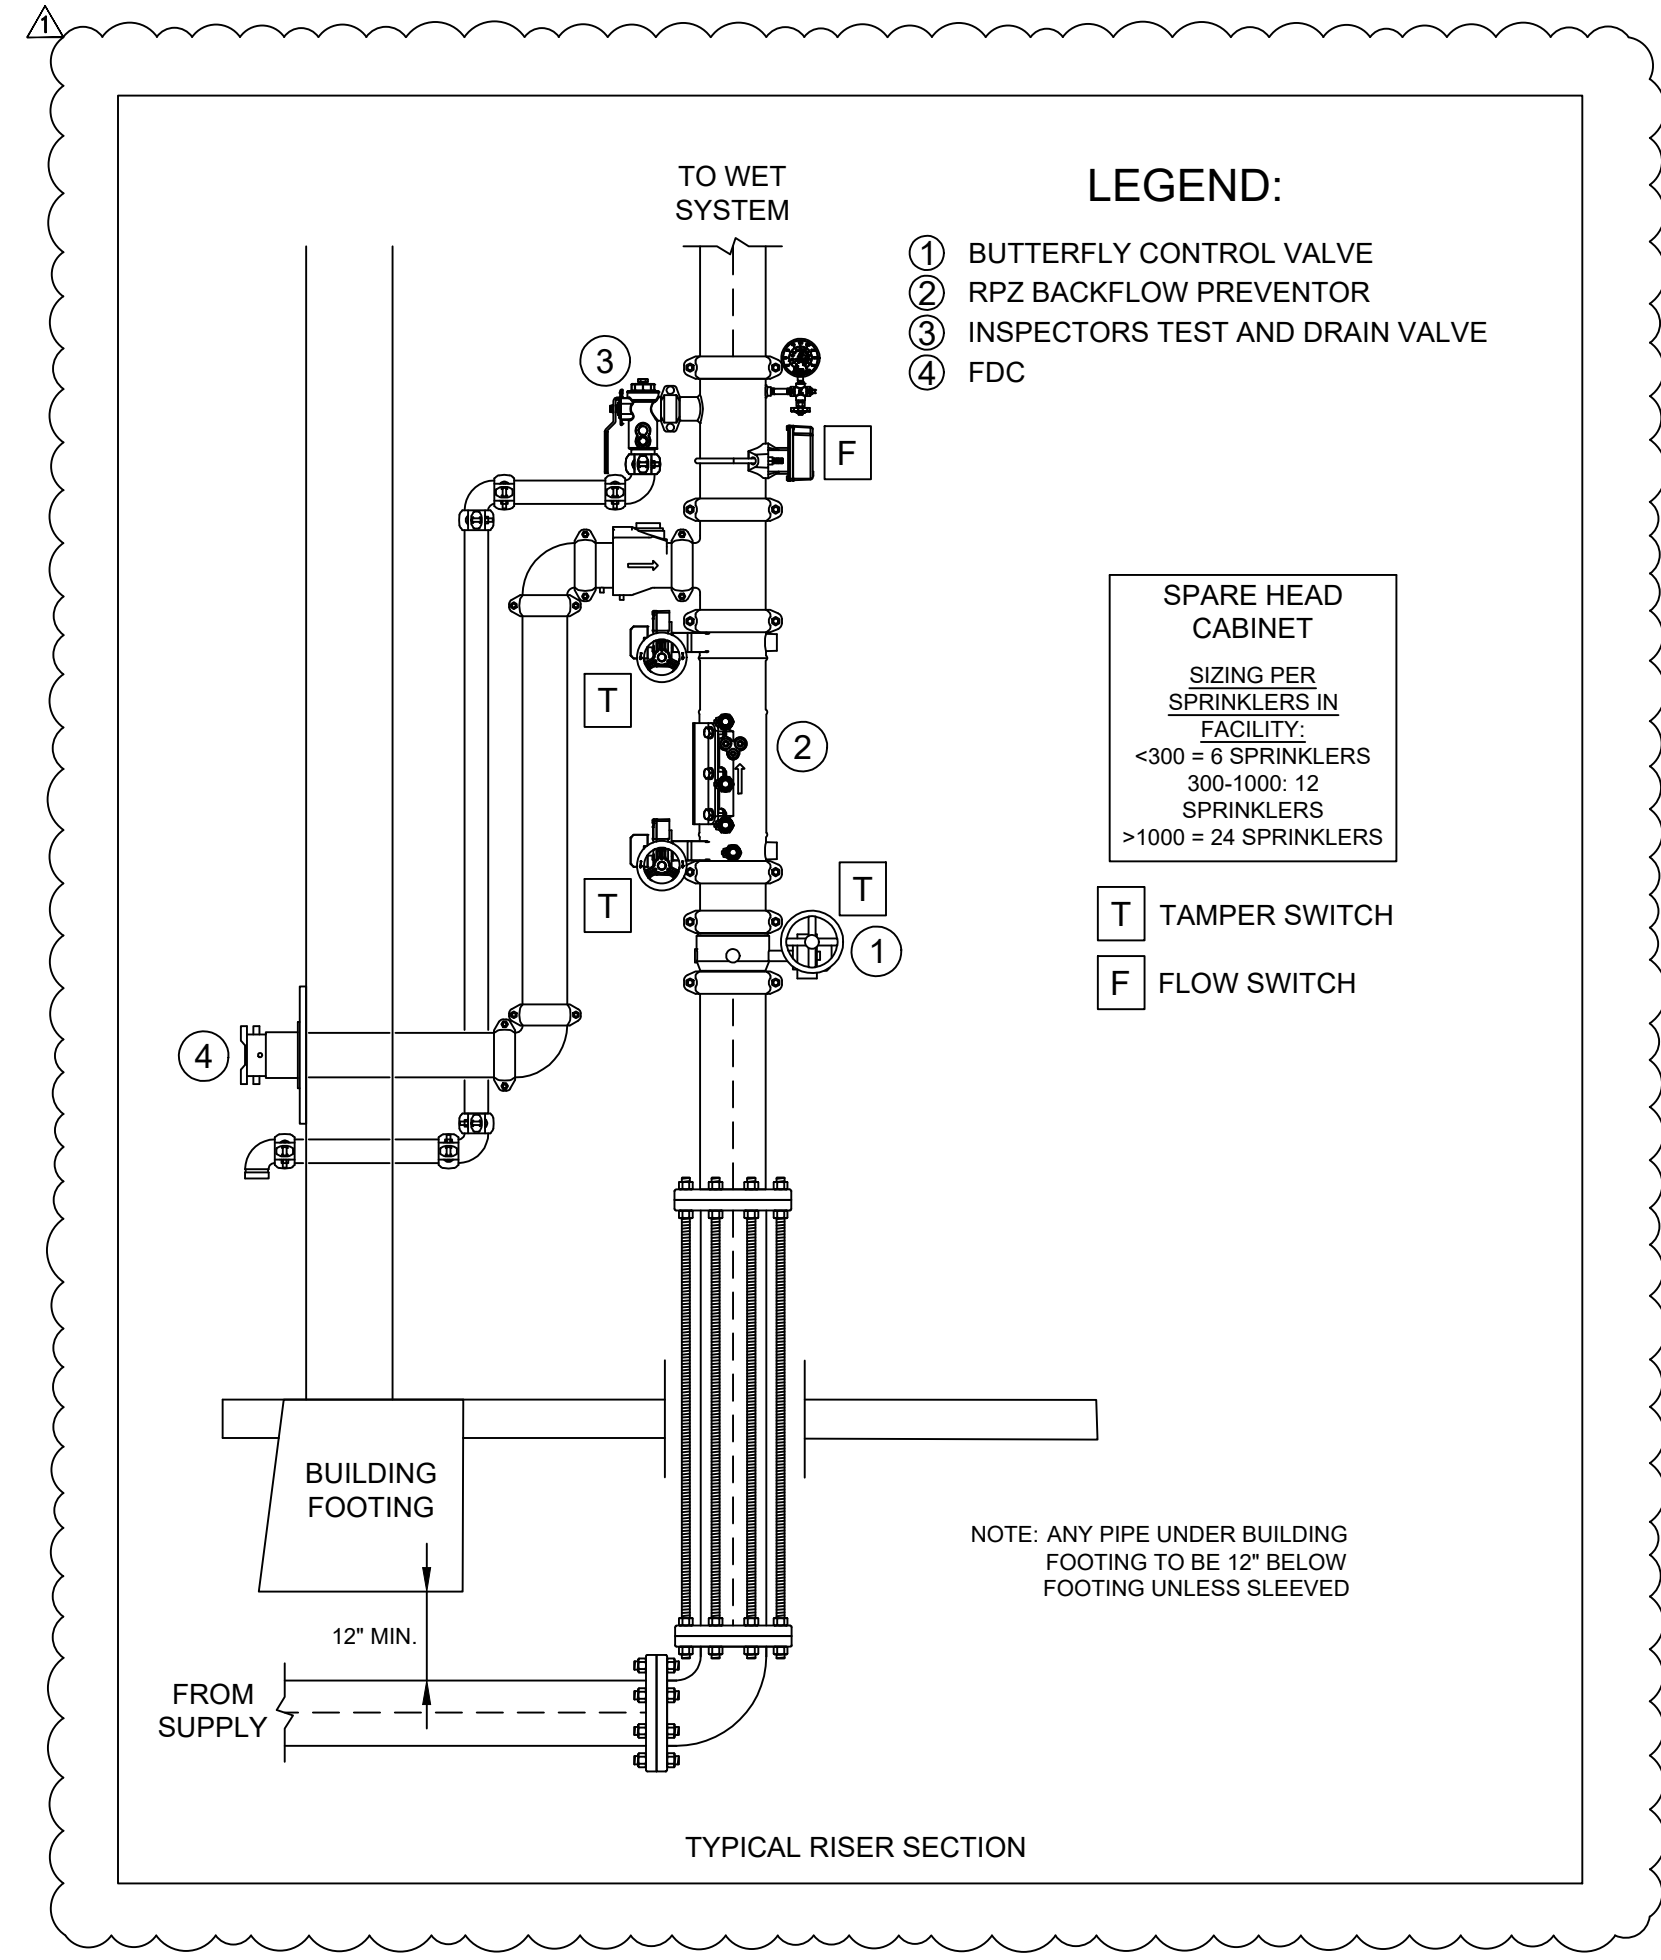

SPRINKLER HEAD KEY

SYMBOL	TYPE	COVERAGE	RESPONSE	K
●	PENDANT	STANDARD	QUICK	5.6
○	UPRIGHT	STANDARD	QUICK	5.6

NOTE: (1) ABOVE HEADS USED FOR SPRINKLER DESIGN INTENT AND CALCULATIONS. SPRINKLER CONTRACTOR RESPONSIBLE FOR FINAL LAYOUT AND SELECTION OF SPRINKLER HEADS.

**FIRE PROTECTION DESIGN CRITERIA**

- .10 GPM/FT<sup>2</sup> OVER 1500 FT<sup>2</sup> LIGHT HAZARD WET SYSTEM
- ▨ .15 GPM/FT<sup>2</sup> OVER 1500 FT<sup>2</sup> ORDINARY HAZARD GROUP 1 WET SYSTEM
- ▩ .20 GPM/FT<sup>2</sup> OVER 1500 FT<sup>2</sup> ORDINARY HAZARD GROUP 2 WET SYSTEM

**FIRE PROTECTION SYMBOLS KEY**

EXIST MAIN	PIPE HANGAR
EXIST BRANCH LINE	SEISMIC SWAY BRACING
NEW MAIN	HYDRAULIC NODE POINT
NEW BRANCH LINE	REMOTE AREA
FIRE RISER	AREA OF NO WORK

**H<sub>E</sub> HOLSTON ENGINEERING, INC.**  
 301 MONTGOMERY ST., SUITE #4, JOHNSON CITY, TN 37604 (423)928-5991 holston.engineering@holsteng.com

This Document is an Instrument of Service and remains copyrighted property of Holston Engineering, Inc. This document shall not be copied/reproduced or used in any manner without express written permission by Holston Engineering, Inc.

PLOT DATE: 06/03/2026 HE PROJECT # 25-010